


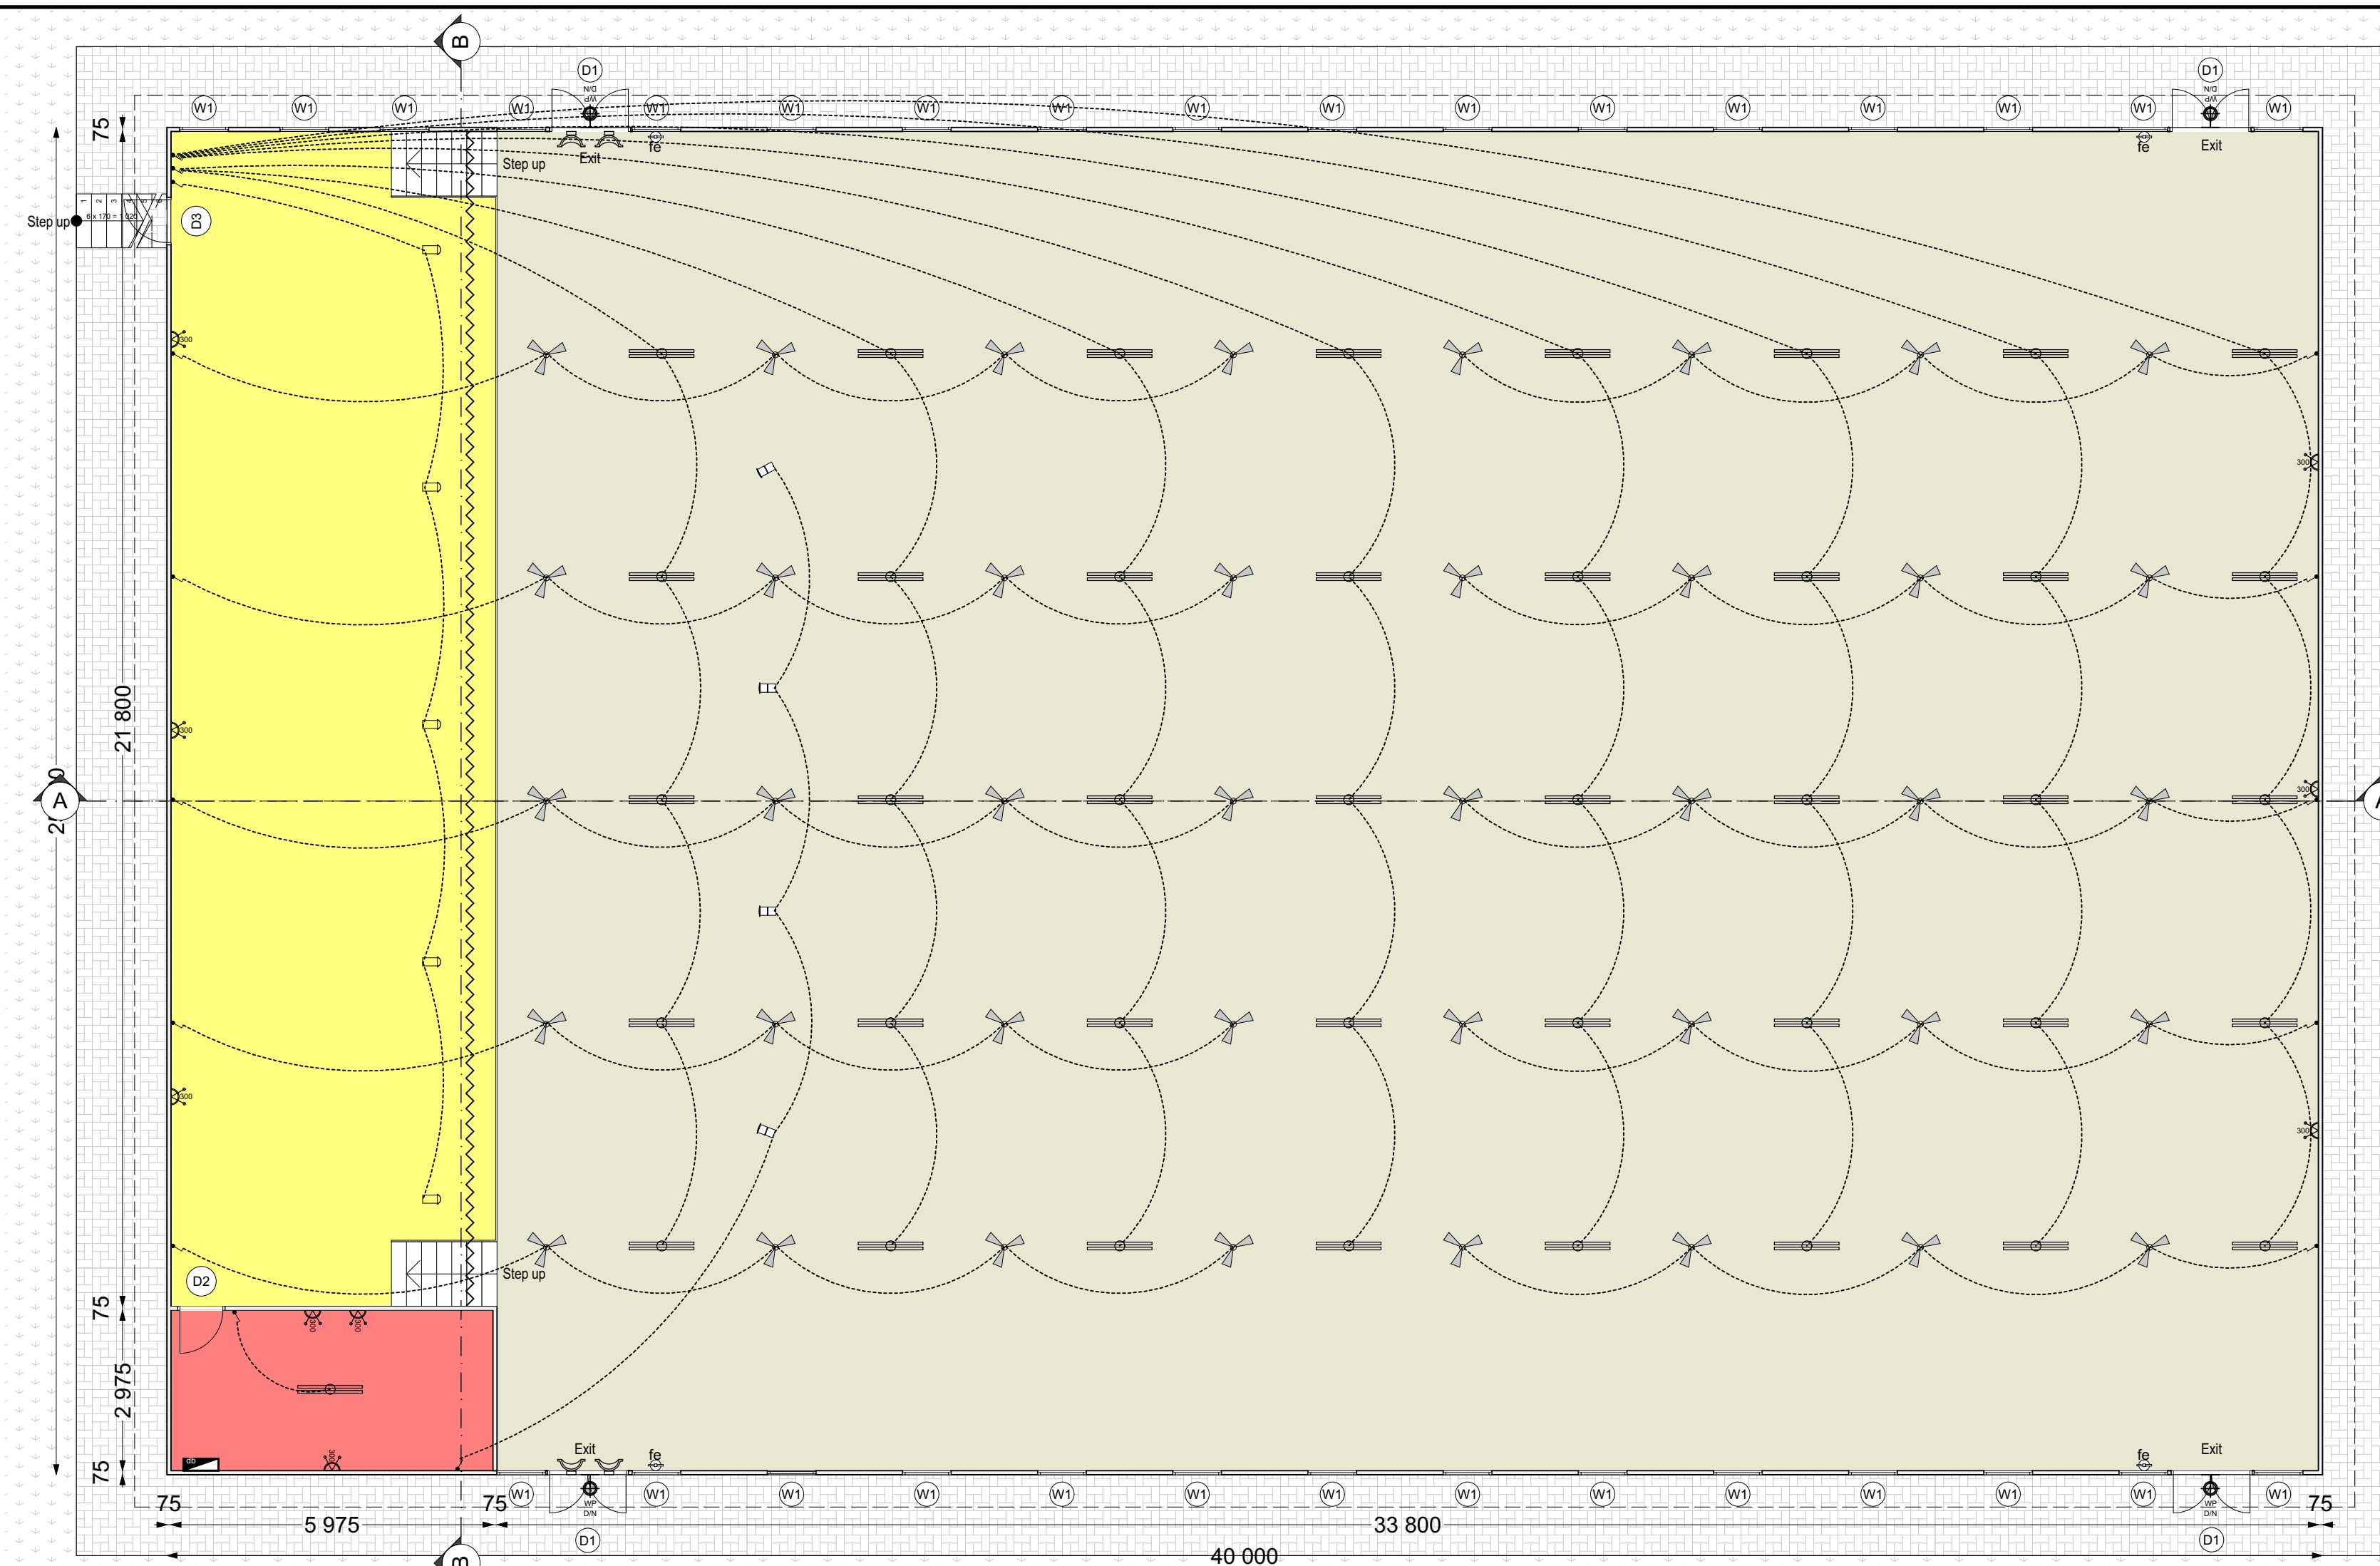

Available Substructures:
- Concrete

Notes:

- COPYRIGHT OF THIS DOCUMENT IS RESERVED BY THE ARCHITECT AND THIS DOCUMENT IS ISSUED ON THE EXPRESS CONDITION THAT NO PART OF IT MAY BE REPRODUCED OR TRANSMITTED TO A THIRD PARTY WITHOUT THE WRITTEN PERMISSION OF THE ARCHITECT
- ALL DIMENSIONS AND LEVEL TO BE CHECKED ON SITE BEFORE ANY WORK IS PUT IN HAND. MUNICIPAL SEWER CONNECTION INVERT LEVEL & SEWER LINE FALLS TO BE CHECKED BEFORE THE CONTRACTOR PROCEED WITH TRENCHES.
- THE DRAWING MAY NOT BE SCALED.
- ANY DISCREPANCIES ARE TO BE IMMEDIATELY REPORTED TO THE ARCHITECT
- ALL WORK IS TO BE CARRIED OUT IN ACCORDANCE WITH THE N.B.R, SABS & SANS 10400 REGULATIONS.

REV NO.	DATE.	DESCRIPTION
---------	-------	-------------

Panelman (PTY) Ltd
Rag no. 2012/085401/07
293 Hendrix van Eck street
Rosslyn
Pretoria
0200
012 941 5808
admin2@pmeng.co.za
victor@pmeng.co.za
arnold@pmeng.co.za

Project title:

Church Or School Hall Unit
(40000x25000)

Drawing title:

Floor plan & persective

Scale: _____ Date: _____

AS SHOWN	2016 - 08 - 25
----------	----------------

Drawn: Checked: Drawing no.

PB	NB	G0003_15_08
----	----	-------------

NOT FOR CONSTRUCTION REVISION: 0